



Drawing name: H:\47873000\CADD\CONSTR\CONSTR CONT AND CRATE\C27-C31-SAN P&P-3000.dwg C28A Nov 05, 2008 1:11pm by: britt.stephens  
 This document, together with the concepts and designs presented herein, is intended only for the specific purpose and client for which it was prepared. Reuse of and improper reliance on this document without written authorization and adaptation by Kimley-Horn and Associates, Inc. shall be without liability to Kimley-Horn and Associates, Inc.

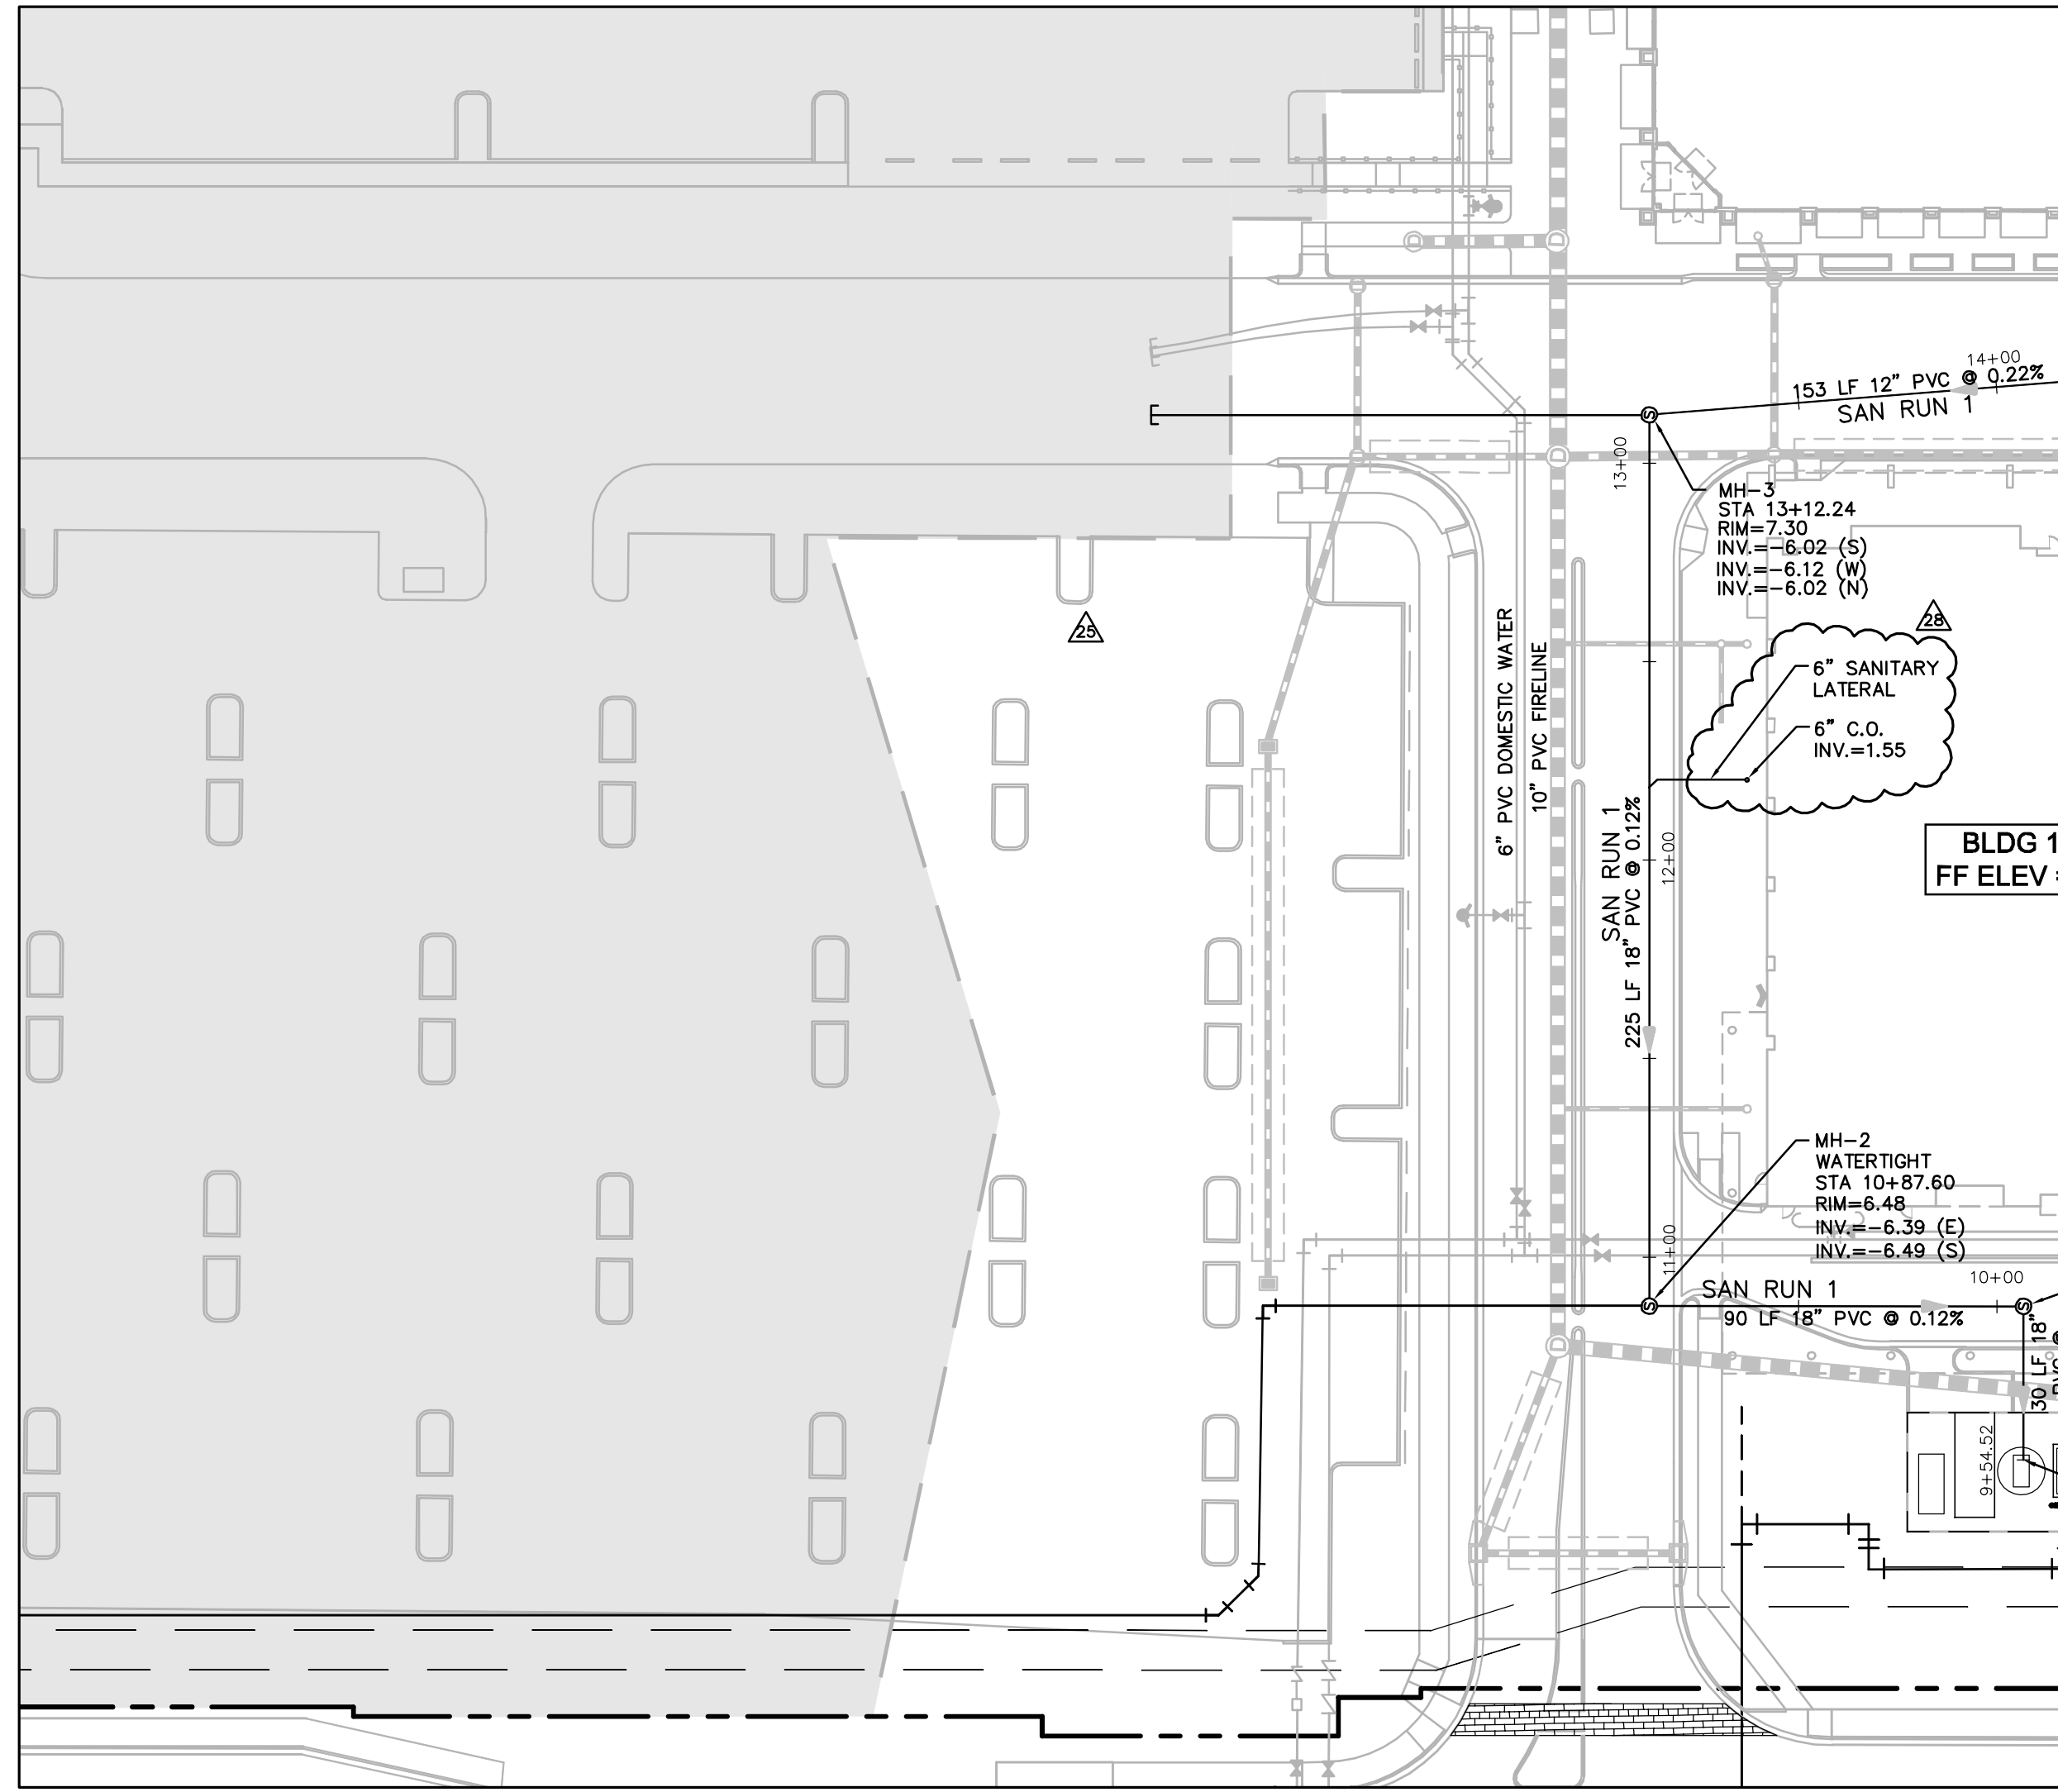

SANITARY PLAN 8

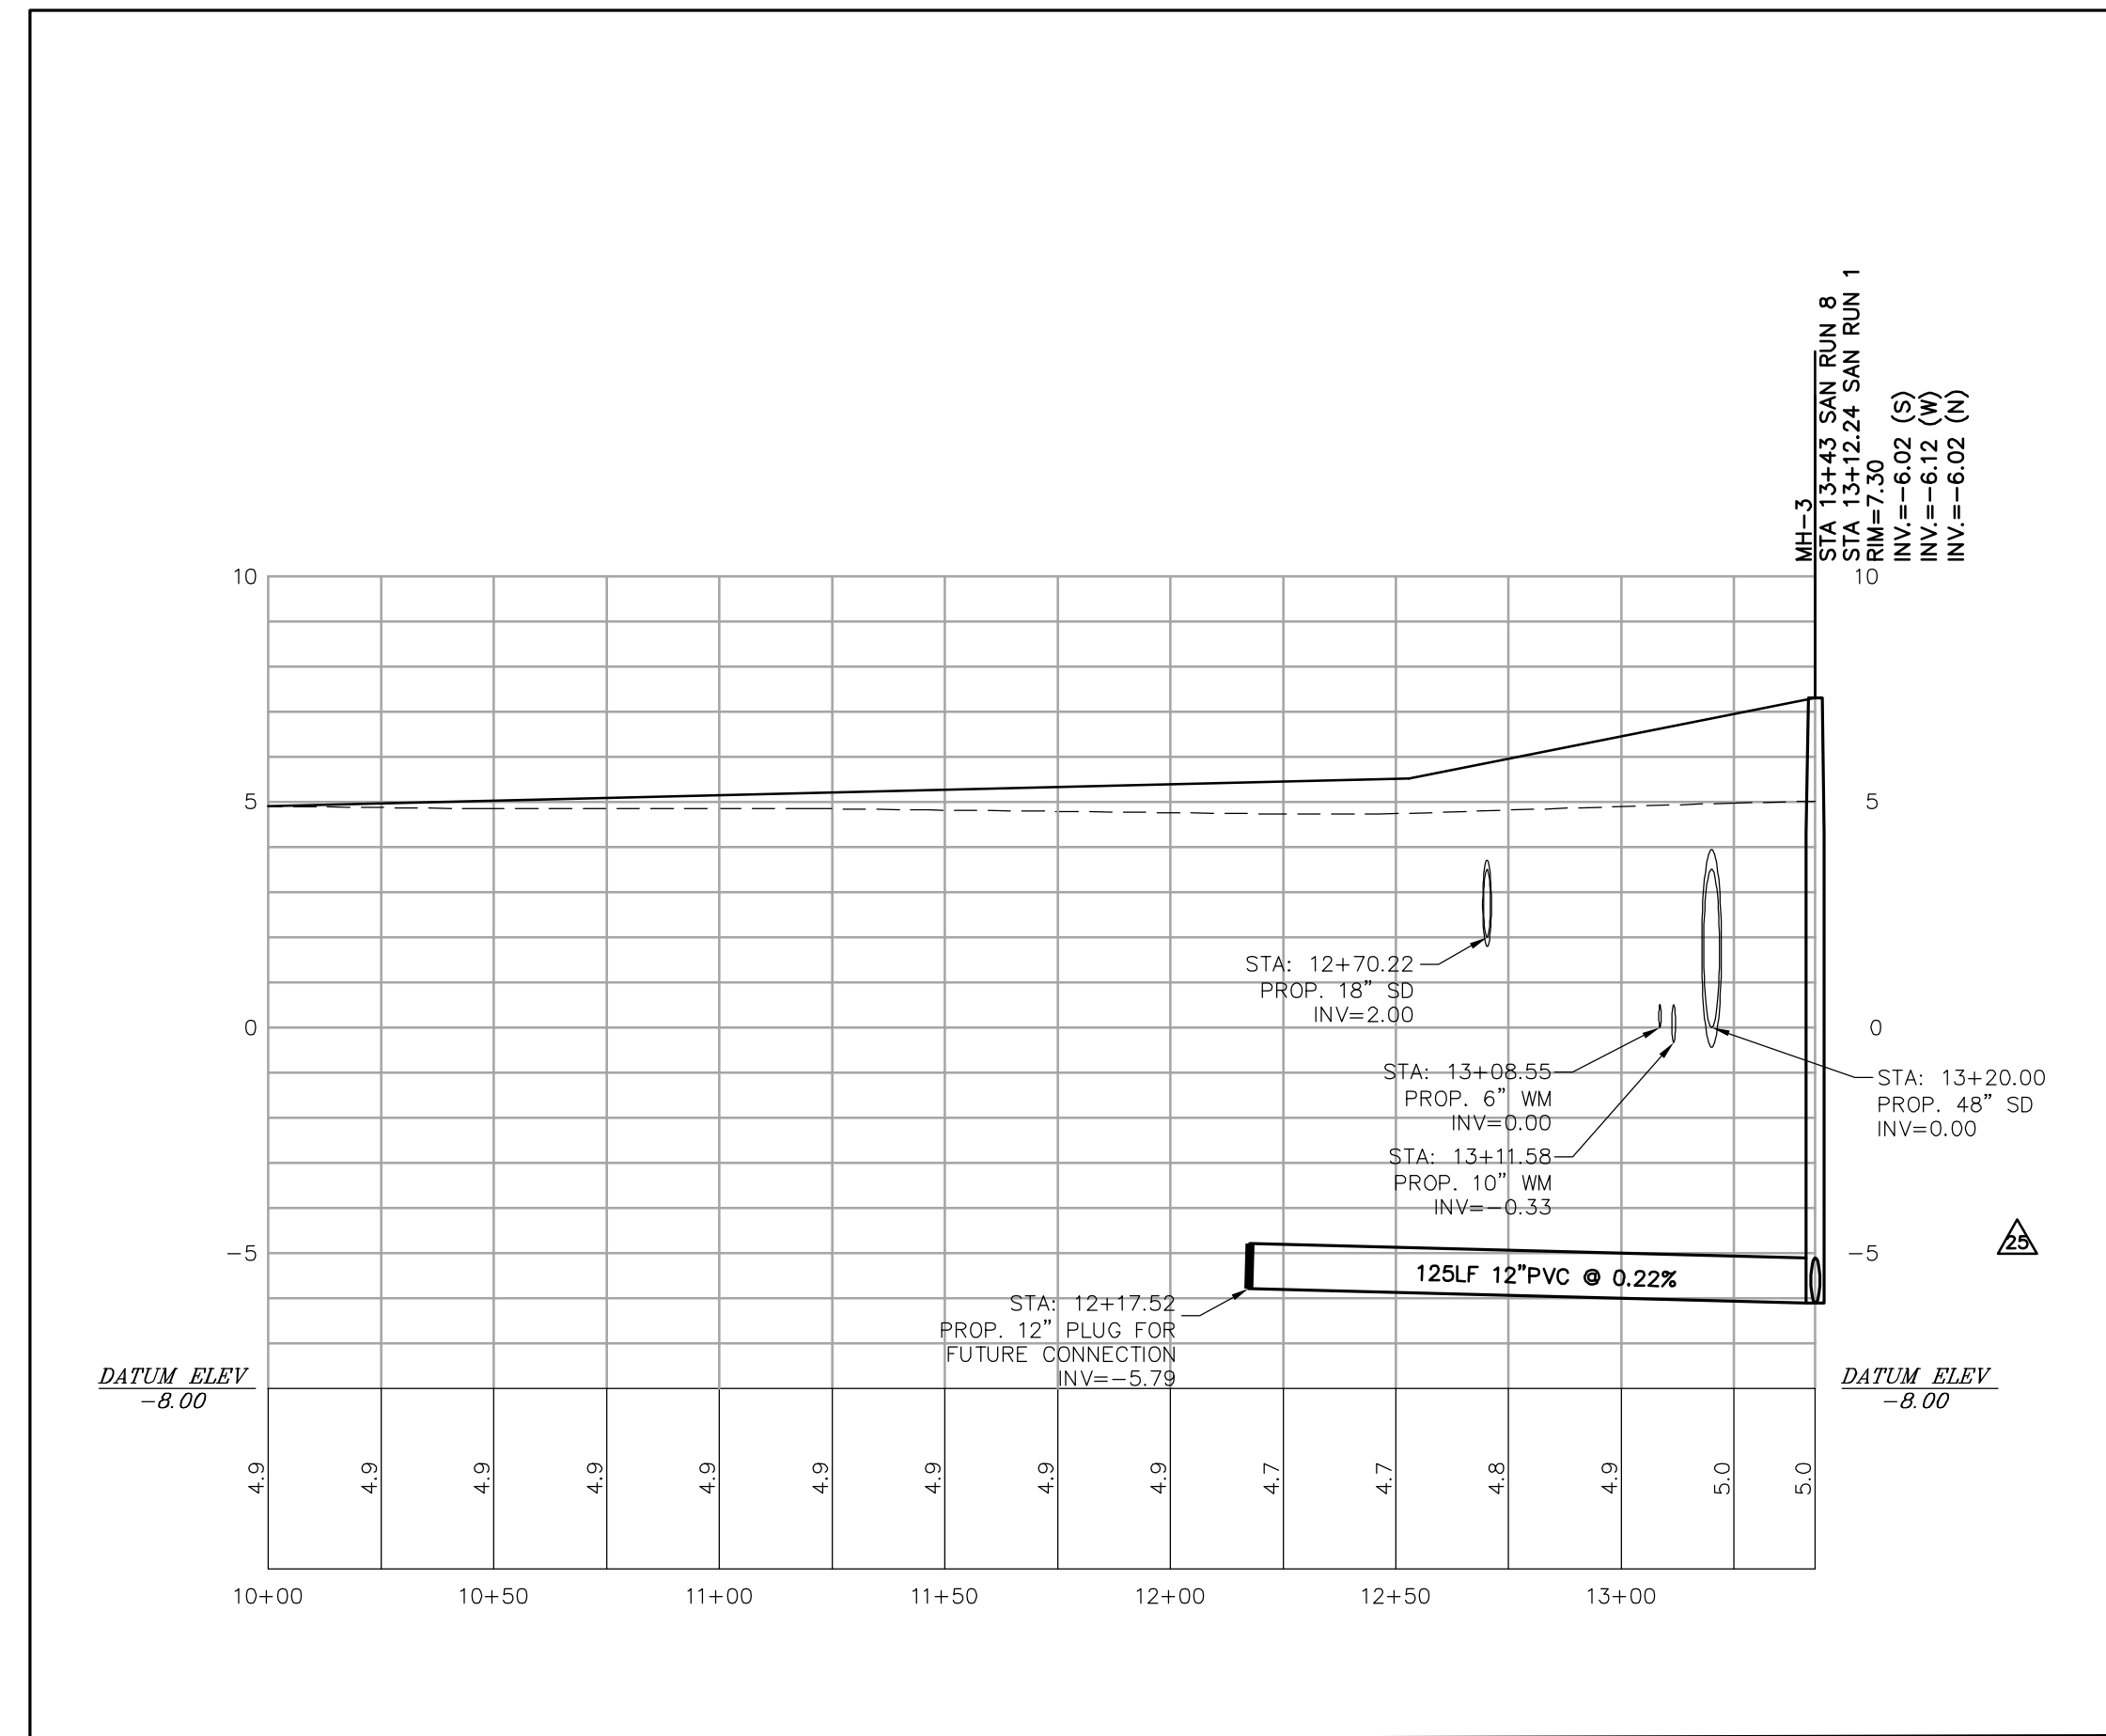

SANITARY PROFILE 8  
 HORIZ. SCALE = 1:40  
 VERT. SCALE = 1:4

PAD ELEVATION TO BE 8"  
 BELOW FINISHED FLOOR ELEVATION

SCALE AS NOTED		DESIGN ENGINEER:	KIMLEY-HORN AND ASSOCIATES, INC.	
DESIGNED BY: MST	ROSCOE L. BIBY, P.E.	601 21st Street, Suite 300, Vero Beach, FL 32960		
DRAWN BY: SAM	FLORIDA REGISTRATION NUMBER:	Phone: (772) 562-7981 Fax: (772) 562-9889		
CHECKED BY: RLB	34789	WWW.KIMLEY-HORN.COM CA 0000696		
SEAL		REVISIONS		
DATE		No.	DATE	BY
5/31/06		11/5/08	11/5/08	PAG
PROJECT NO. 047873000		9/29/08	9/29/08	SDW
SHEET NUMBER C28A		9/9/08	9/9/08	ESM

SANITARY SEWER  
 PLAN AND PROFILE

VILLAGE AT  
 GULFSTREAM PARK  
 PHASE 1

BROWARD COUNTY  
 FLORIDA